

STANDARD ABBREVIATIONS			
A	@	AT	LAM
	AB	ANCHOR BOLT	LAV
	A/C	AIR CONDITIONING	LBS
	ACI	AMERICAN CONCRETE INSTITUTE	LTG
	ADJ	ADJACENT OR ADJUSTABLE	LVR
B	ALUM	ALUMINUM	M
	APPROX	APPROXIMATELY	MAS
	ASTM	AMERICAN SOCIETY FOR TESTING AND MATERIALS	MAX
			MECH
			MFR
C	BLDG	BUILDING	MIN
	BLK	BLOCKING	MISC
	BM	BEAM OR BENCH MARK	MO
	BOT	BOTTOM	MTD
	BRG	BEARING	MTL
D			N
	CI	CAST IRON	NEC
	CJ	CONTROL JOINT	NEMA
	CL	CENTER LINE	NFPA
	CLG	CEILING	NIC
E	CLO	CLOSET	NO
	CLR	CLEAR	NOM
	CMU	CONCRETE MASONRY UNIT	NTS
	COL	COLUMN	
	CONC	CONCRETE	O
F	CONST	CONSTRUCTION	OC
	CONT	CONTINUOUS	OD
	CORR	CORRIDOR	OFD
	CPT	CARPET	OH
	CT	CERAMIC TILE	OPNG
G	CTR	CENTER	OZ
	CW	COLD WATER	
			P
			PL
			PLAS
H	DTL	DETAIL	PLBG
	DIA	DIAMETER	PLWD
	DM	DIMENSION(ED)	PNL
	DN	DOWN	PSF
	DWG	DRAWING	PSI
I			PT
	EA	EACH	PTD
	EJ	EXPANSION JOINT	PVC
	ELEC	ELECTRICAL	
	ELEV	ELEVATION OF ELECTRICAL	R
J	EOS	EDGE OF SLAB	RCP
	EQ	EQUAL	RD
	EQUIP	EQUIPMENT	RECPT
	EW	ELECTRIC WATER COOLER	REINF
	EWX	ELECTRIC WATER HEATER	REQD
K	EXH	EXHAUST	RM
	EXT	EXTERIOR OR EXTERNAL	ROW
			RP
			S
			SATC
L	FD	FLOOR DRAIN	SECT
	FEC	FIRE EXTINGUISHER CABINET	SE
	FFE	FINISHED FLOOR ELEVATION	SHT
	FHC	FIRE HOSE CABINET	SIM
	FLUOR	FLUORESCENT	SPEC
M	FOM	FACE OF MASONRY	SS
	FT	FOOT OR FEET	STD
	FTG	FOOTING	STC
			STL
			STRUCT
N	GA	GAUGE	SQ
	GALV	GALVANIZED	SV
	GB	GRAB BAR	
	GL	GLASS OR GLAZING	T
	GBW	GYP	TA
O	GYP	GYP	TEL
			T&G
			TOB
			TOC
			TOF
P	H8	HOSE BIBB	TOS
	HCP	HANDICAP	TOW
	HDW	HARDWARE	TP
	HID	HIGH INTENSITY DISCHARGE	TPD
	HM	HOLLOW METAL	TPY
Q	HORIZ	HORIZONTAL	
	HR	HOUR	UL
	HT	HEIGHT	UNO
	HTG	HEATING	
	HTR	HEATER	V
R	HVAC	HTG, VENTILATION & AIR CONDITIONING	VCT
	HW	HOT WATER	VERT
			VTR
			VWC
			W
S	ID	INSIDE DIAMETER	WC
	INCAN	INCANDESCENT	WD
	INCL	INCLUDING	WH
	INSUL	INSULATION	W/O
	INT	INTERIOR OR INTERNAL	WP
T	JAN	JANITOR	WWF
	JT	JOINT	
	JST	JOIST	Y
	KIT	KITCHEN	YD



PROJECT TEAM

OWNER

ORANGE COUNTY ABC
601 VALLEY FORGE ROAD
HILLSBOROUGH, NC 27278-2515
T: 919.732.3432 F: -
E: OCABC@MINDSPRING.COM
CONTACT: TONY DUBOIS

STRUCTURAL


KAYDOS-DANIELS ENGINEERS, PLLC
400-201 W. MORGAN STREET
RALEIGH, NC 27603-1807
T: 919.828.4966 F: 919.828.4967
E: LUCAS@KAYDOS-DANIELS.COM
CONTACT: LUCAS G. A. GELO

ARCHITECT

TISE-KIESTER ARCHITECTS, PA
119 EAST FRANKLIN STREET, SUITE 300
CHAPEL HILL, NC 27514
T: 919.967.0158 F: 919.967.0159
E: PKIESTER@TISEKIESTER.COM
CONTACT: PHIL KIESTER

P,M & E

ATLANTEC ENGINEERS, PA
3221 BLUE RIDGE ROAD, SUITE 113
RALEIGH, NC 27612
T: 919.571.1111 F: 919.571.1114
E: DAVID@ATLANTECENGINEERS.COM
CONTACT: DAVID WHITNEY

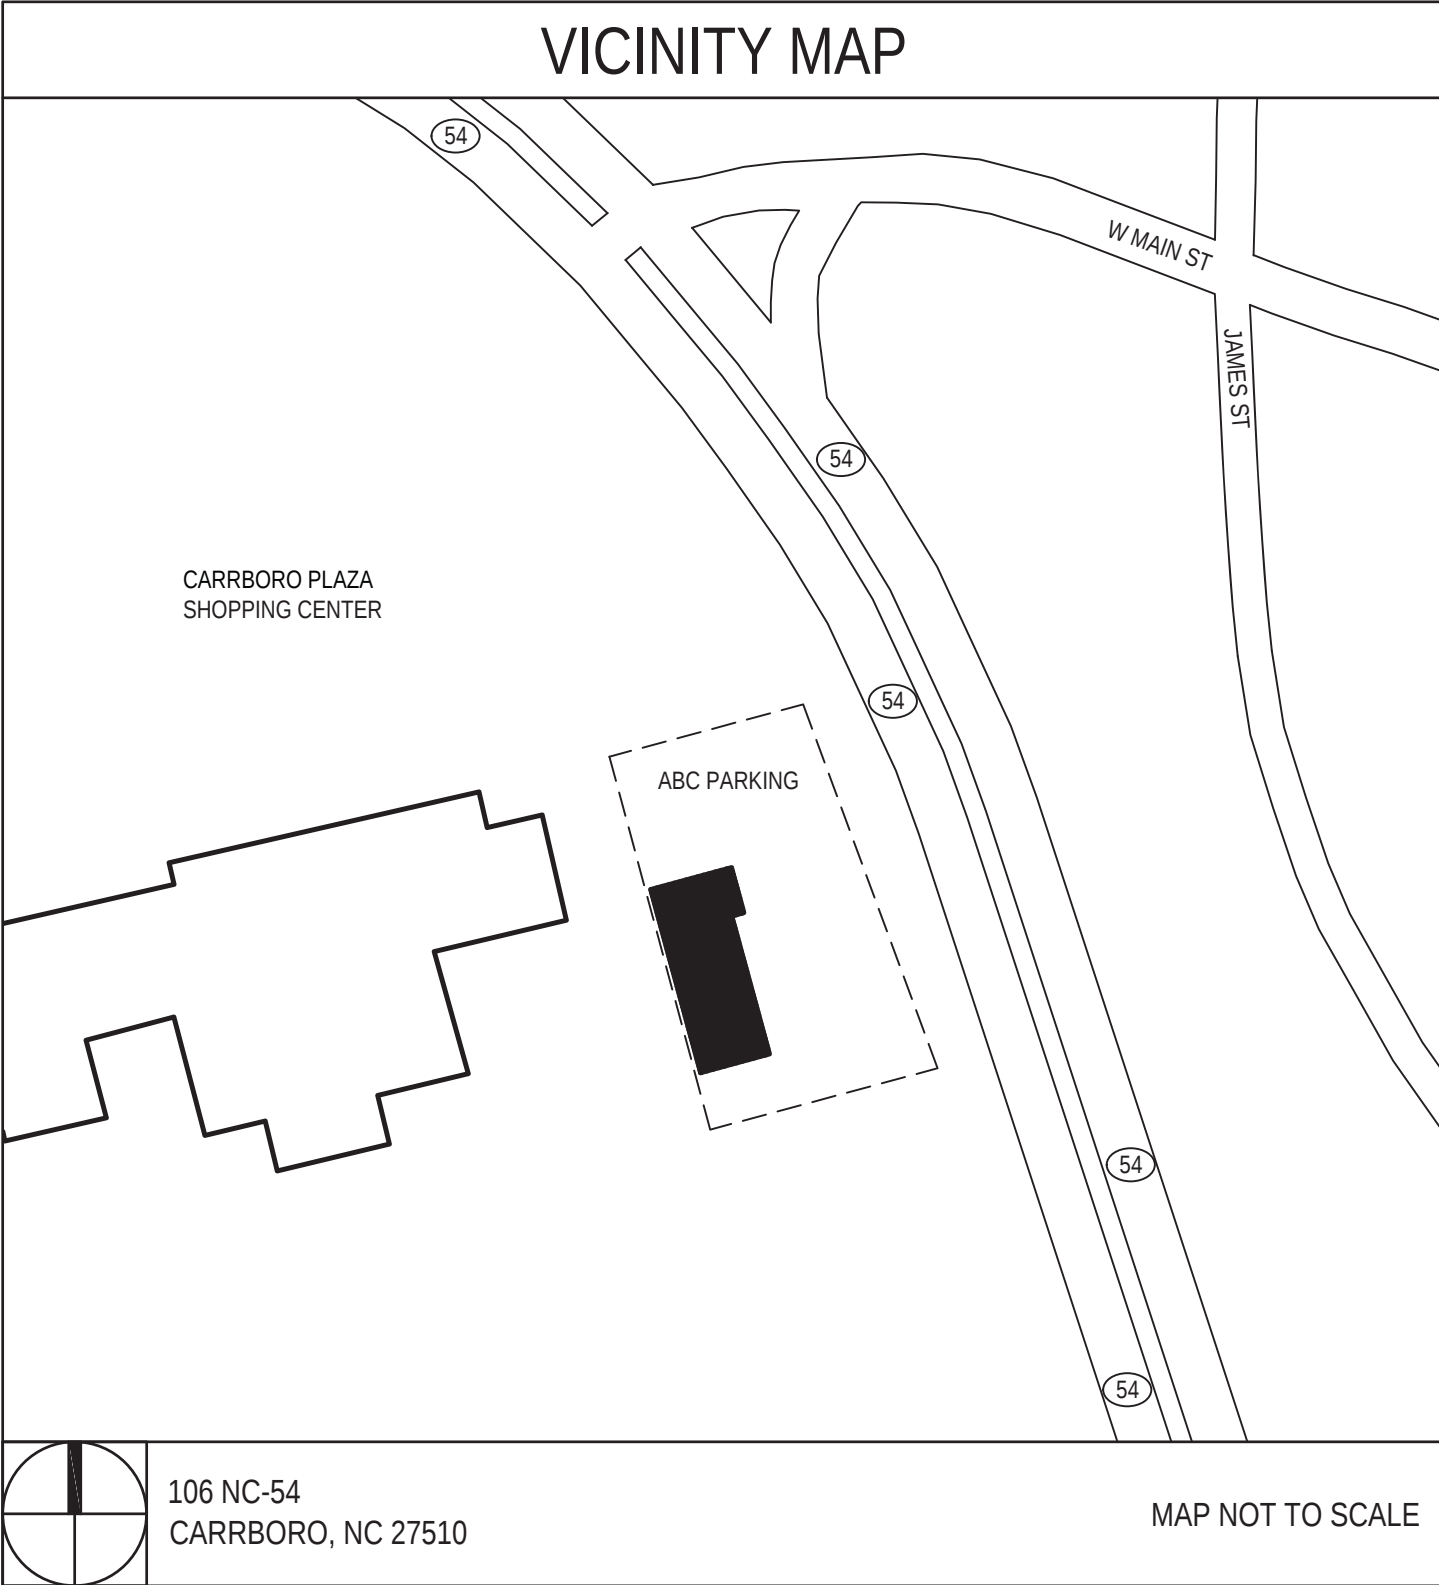

TISE · KIESTER
ARCHITECTS

119 E. Franklin St. Suite 300
Chapel Hill, NC 27514
Tel: 919.967.0158
Fax: 919.967.0159
www.tisekiester.com

These drawings have been commissioned for this construction project and remain the property of Tise-Kiester Architects. No reproduction or use is allowed without first obtaining the Architect's written consent.

Carrboro
ABC

Carrboro, NC



Job Number:

1716

Date:

1.12.18

Revisions:

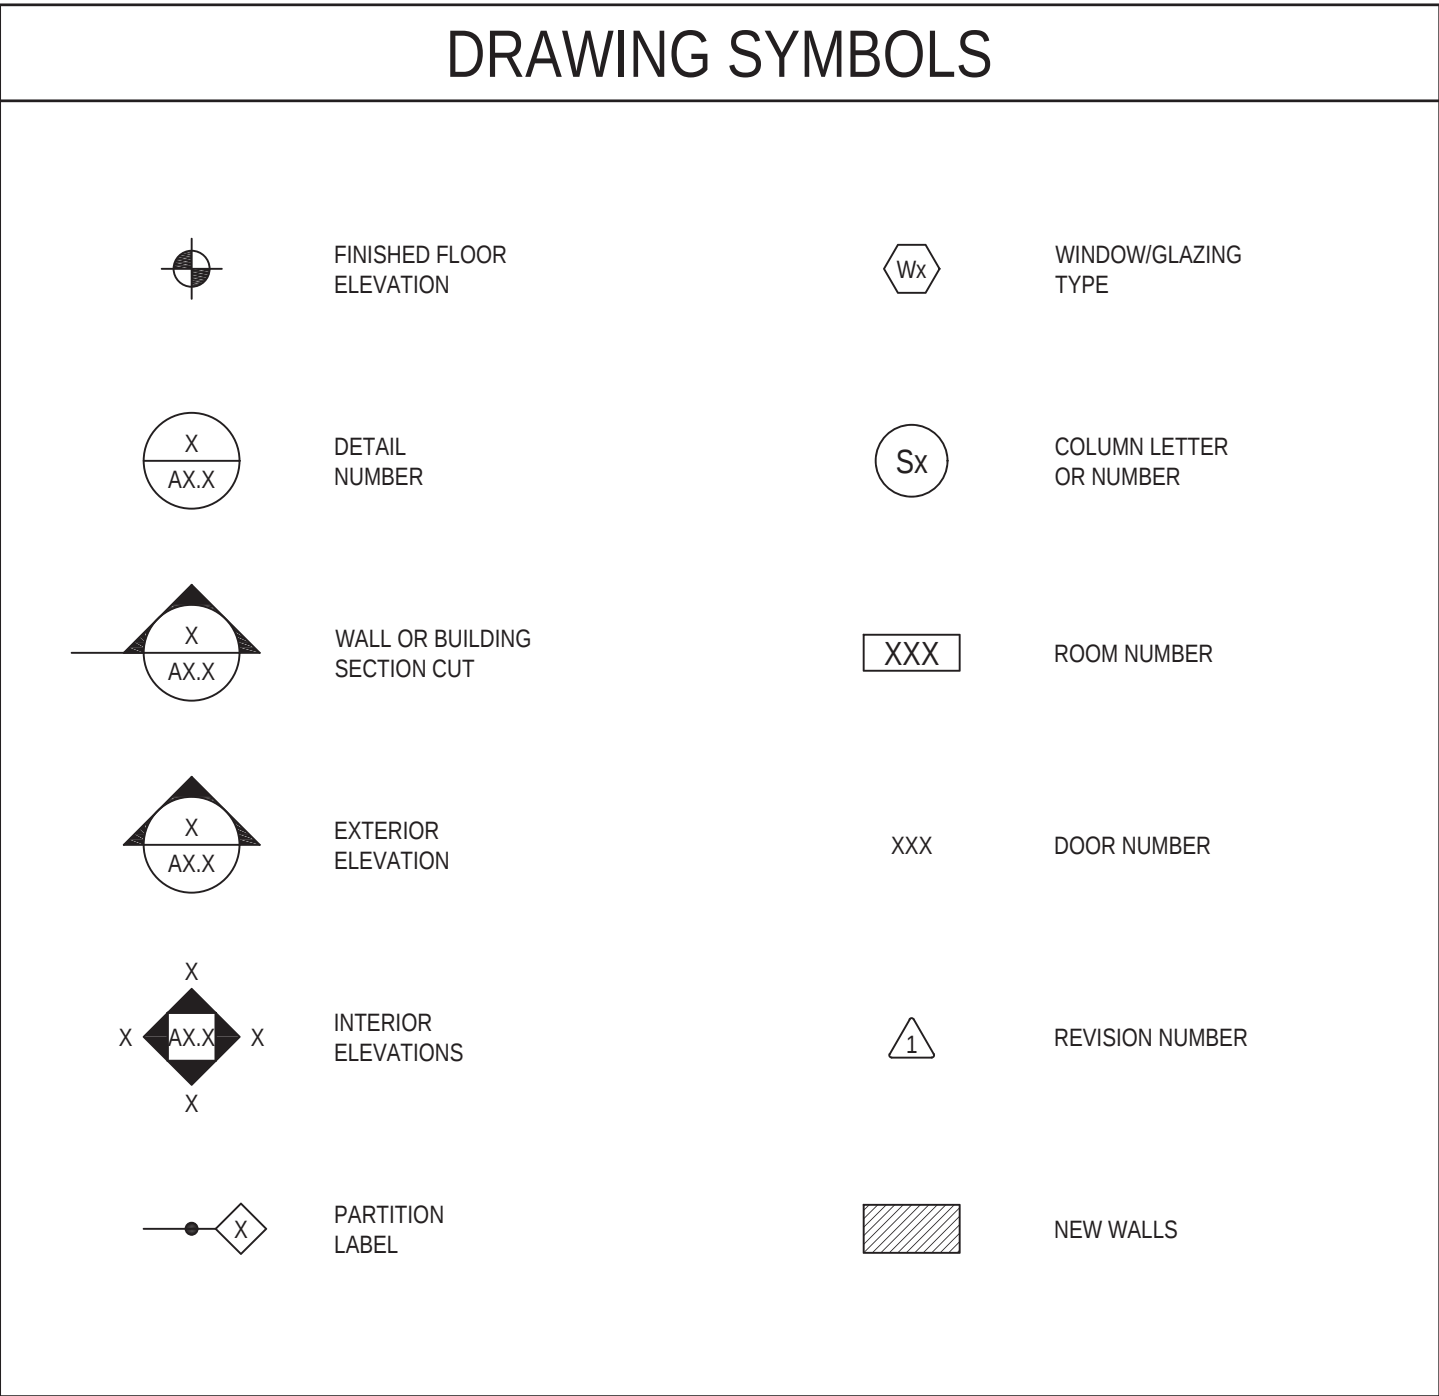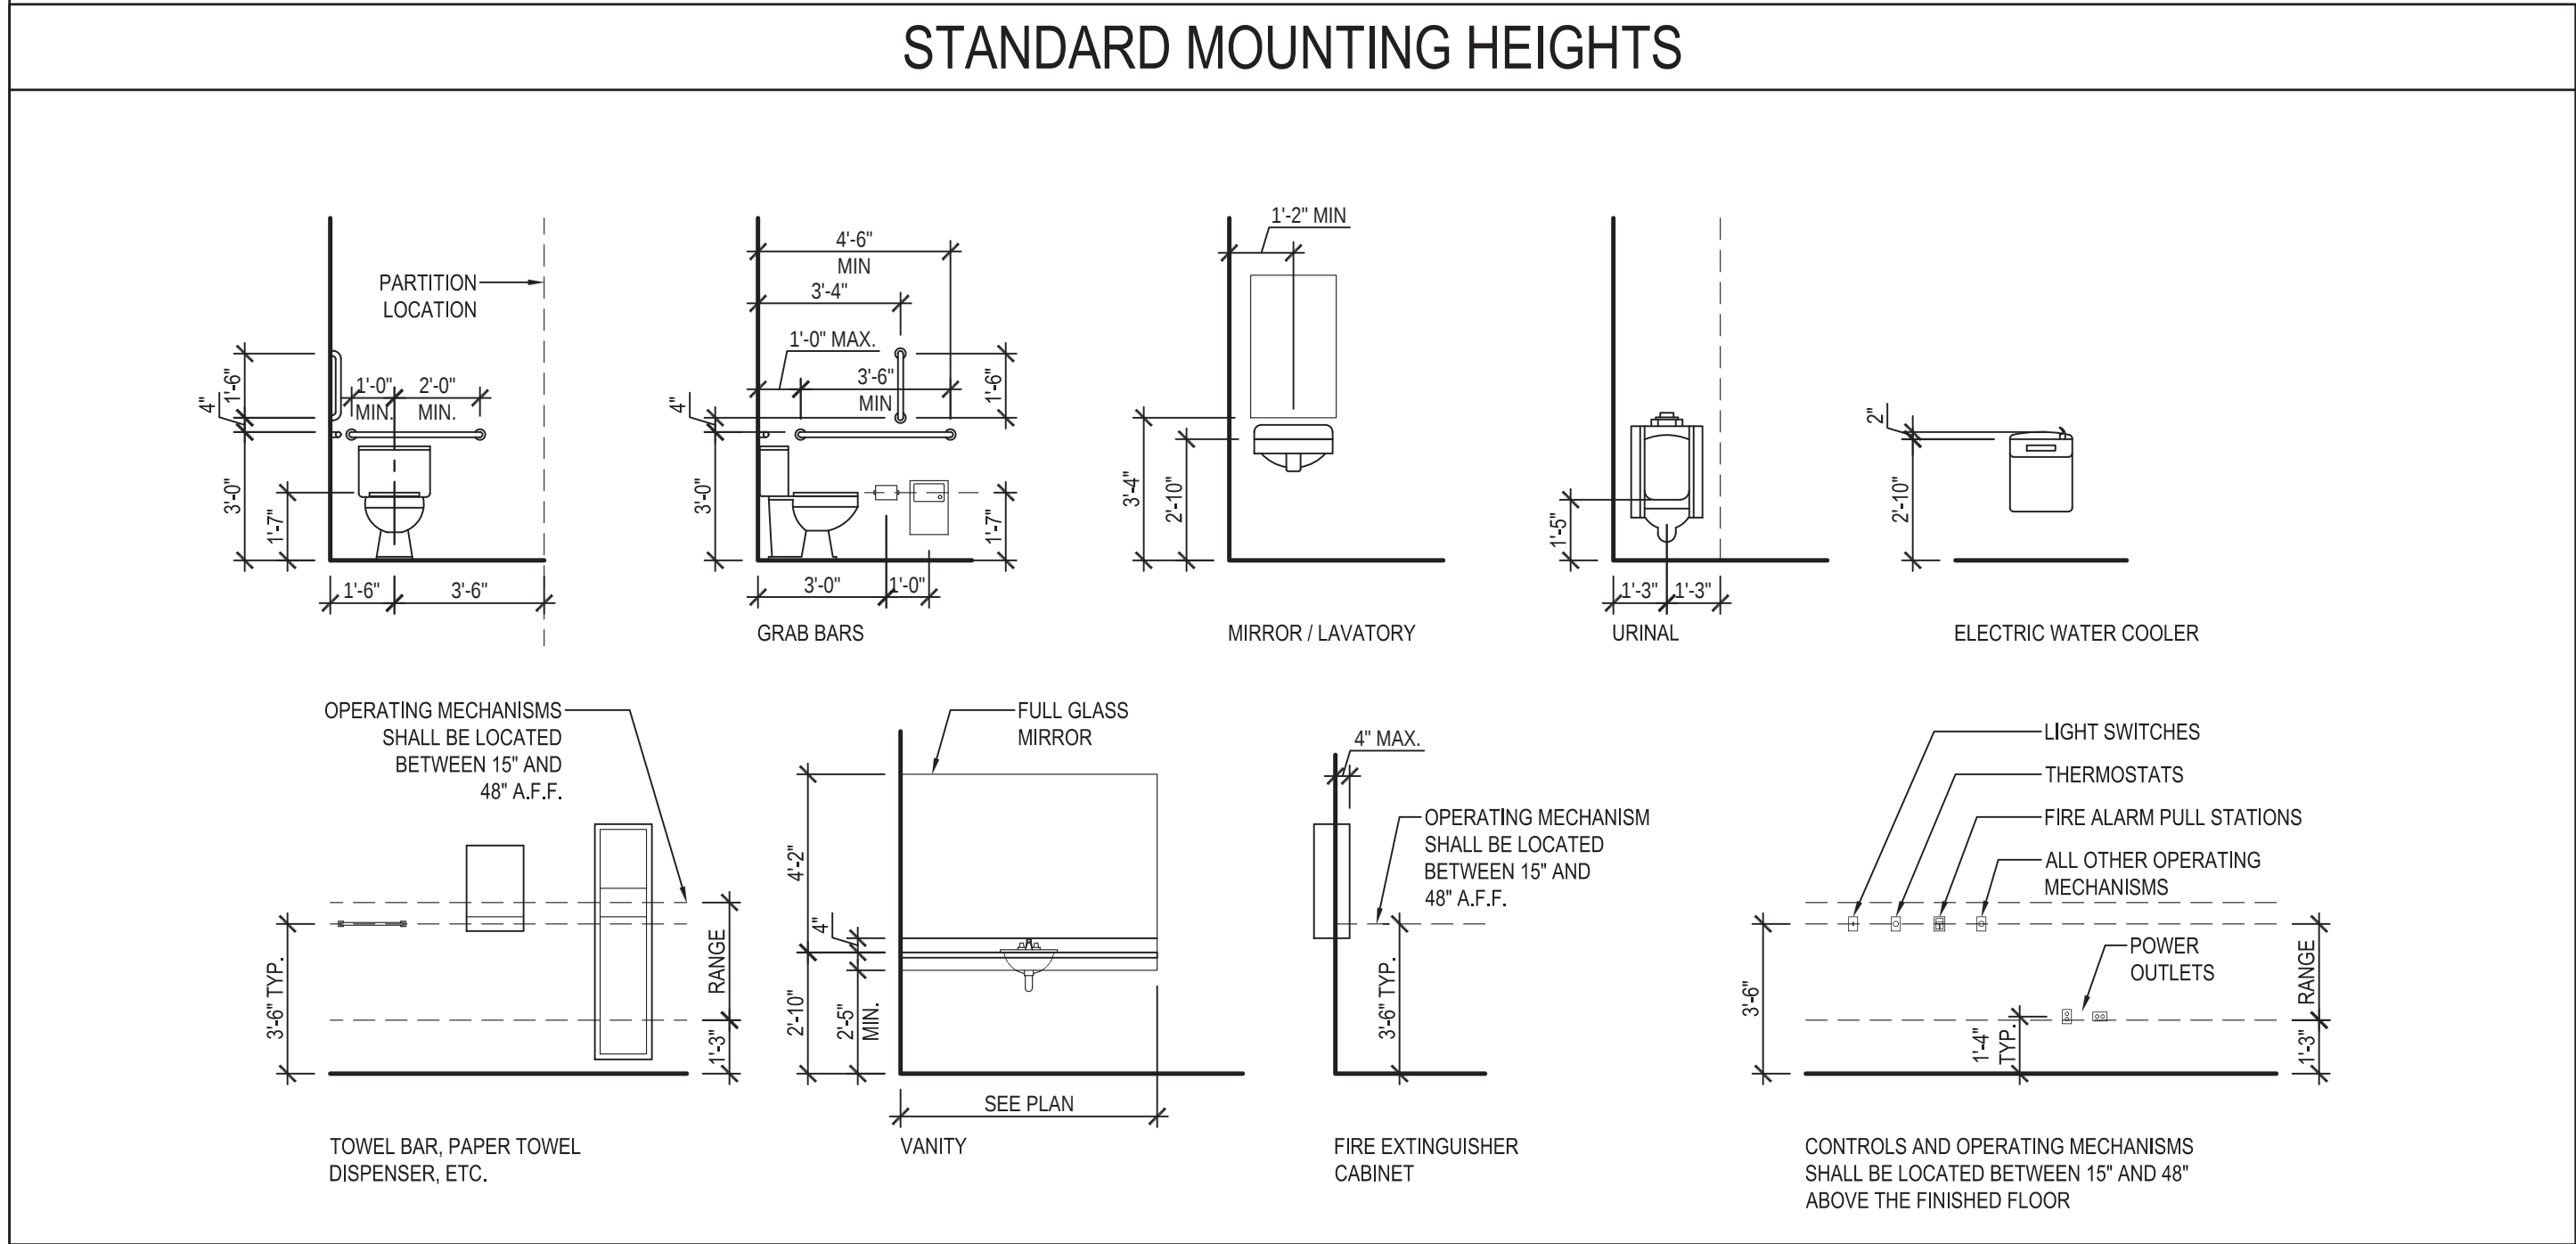

INDEX OF DRAWINGS	
COVER SHEETS	STRUCTURAL
CS1 COVER SHEET, STANDARDS, INDEX	S1.0 GENERAL NOTES & TYPICAL DETAILS
CS2.1A BUILDING CODE SUMMARY (APPENDIX B) - RETAIL BUILDING	S1.1 TYPICAL DETAILS
CS2.1B BUILDING CODE SUMMARY (APPENDIX B) - STOCK BUILDING	S2.0 ROOF FRAMING PLAN
CS2.2 REQUIRED PLUMBING FIXTURES SPREADSHEET	S3.0 STRUCTURAL SECTIONS
CS3.1 LIFE SAFETY PLAN	
SITE	PLUMBING
C1.1 SITE DEMOLITION PLAN	P1.1 PLUMBING PLAN
C2.1 SITE PLAN	P2.1 PLUMBING NOTES AND DETAILS
C3.1 ENLARGED SITE PLAN	
DEMOLITION	MECHANICAL
D1.1 DEMOLITION PLAN	M1.1 MECHANICAL PLAN
D1.2 DEMOLITION ELEVATIONS	M2.1 MECHANICAL SCHEDULES AND DETAILS
ARCHITECTURAL	ELECTRICAL
A1.1 FLOOR PLAN	E1.1 ELECTRICAL POWER PLAN
A1.2 CLERESTORY PLAN	E1.2 ELECTRICAL LIGHTING PLAN
A2.1 ROOF PLAN	E2.1 ELECTRICAL RISER, SECTIONS AND PANEL SCHEDULES
A3.1 BUILDING ELEVATIONS	E2.2 ELECTRICAL DETAILS AND LIGHTING SCHEDULE
A5.1 WALL SECTIONS	E2.3 ELECTRICAL LEGEND, NOTES AND DETAILS
A5.2 WALL SECTIONS	
A5.3 WALL SECTIONS	
A5.4 WALL SECTIONS	
A6.1 ENLARGED PLANS & INTERIOR ELEVATIONS	
A6.2 ENLARGED PLANS & INTERIOR ELEVATIONS	
A8.1 REFLECTED CEILING PLAN	
A9.1 FLOOR FINISHES PLAN	
A10.1 DOOR SCHEDULE, DOOR & FRAME TYPES, WINDOW TYPES	

COVER SHEET

Sheet

CS1

These drawings have been commissioned for this construction project and remain the property of Tise-Kiester Architects. No reproduction or use is allowed without first obtaining the Architect's written consent.


Carrboro
ABC

Carrboro, NC

Job Number: 1716

■ Date: 1.12.18


■ Revisions:

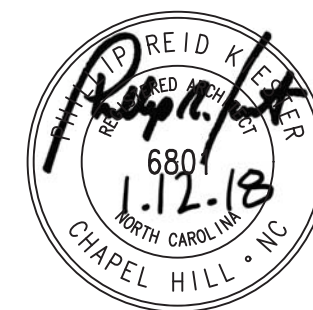

SITE DEMOLITION PLAN

Sheet

C1.1

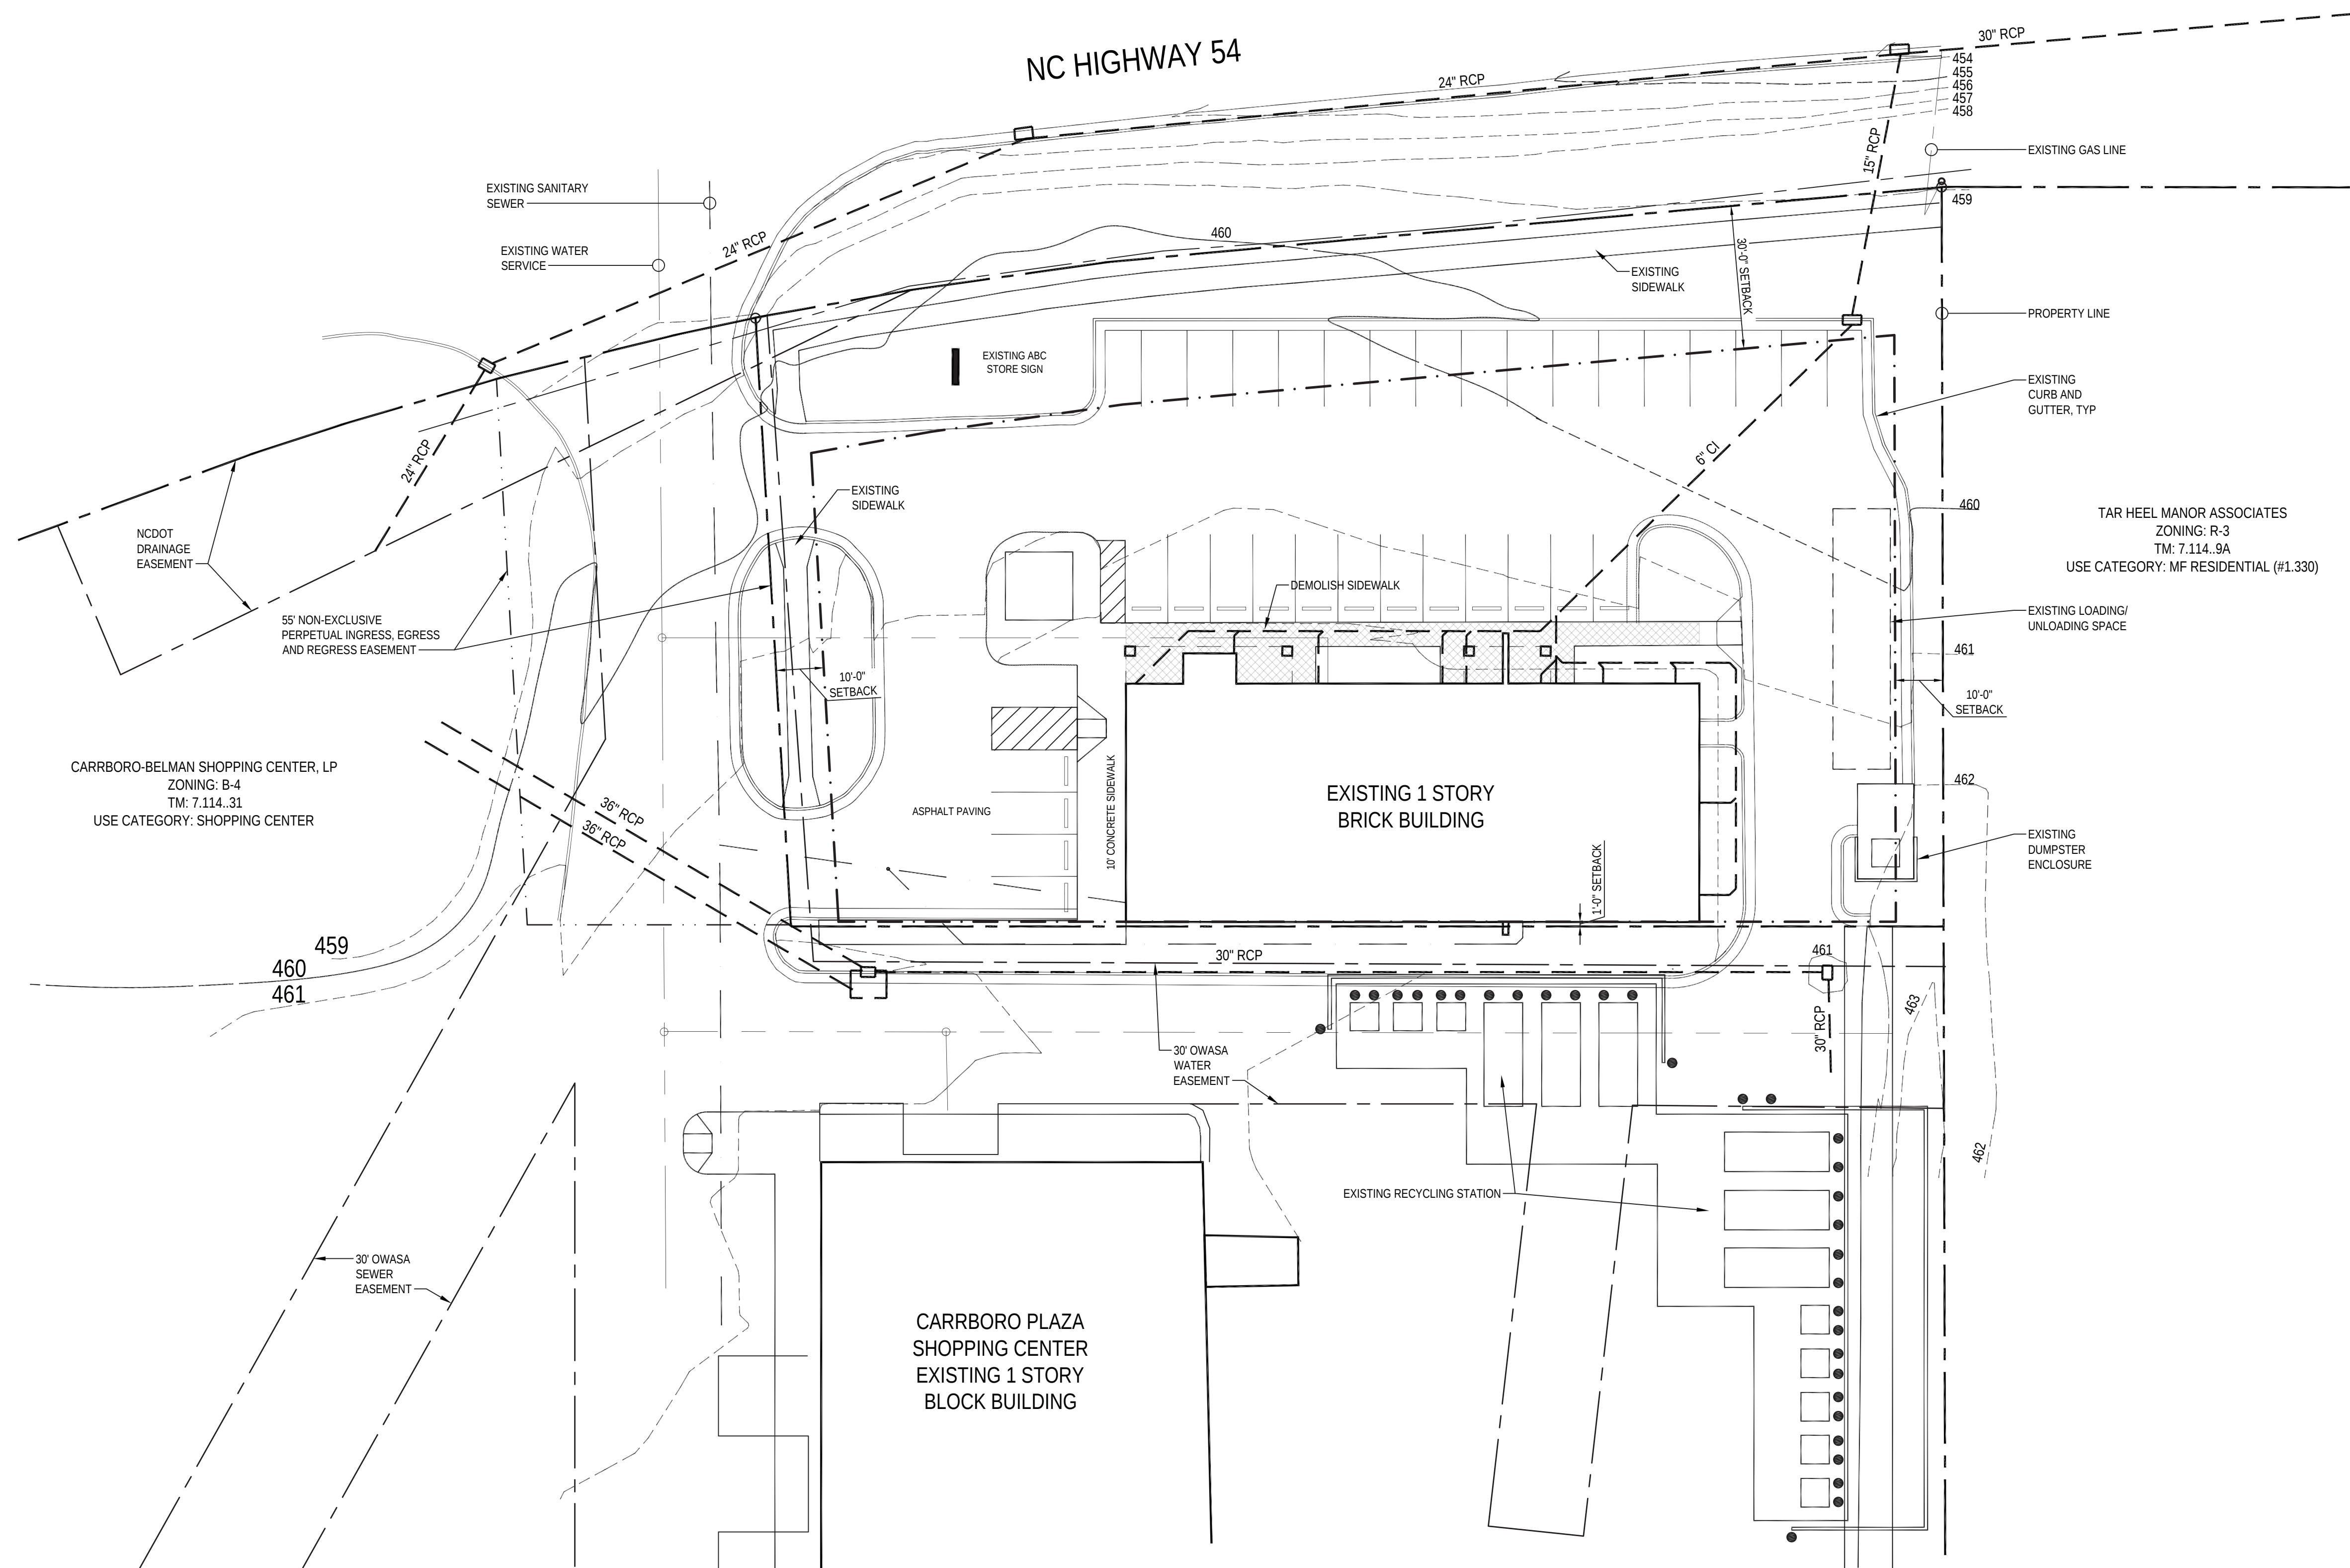

These drawings have been commissioned for this construction project and remain the property of Tise-Kiester Architects. No reproduction or use is allowed without first obtaining the Architect's written consent.

Carrboro ABC


Carrboro, NC

Job Number: 1716
Date: 1.12.18
Revisions:



SITE PLAN
Sheet

C2.1

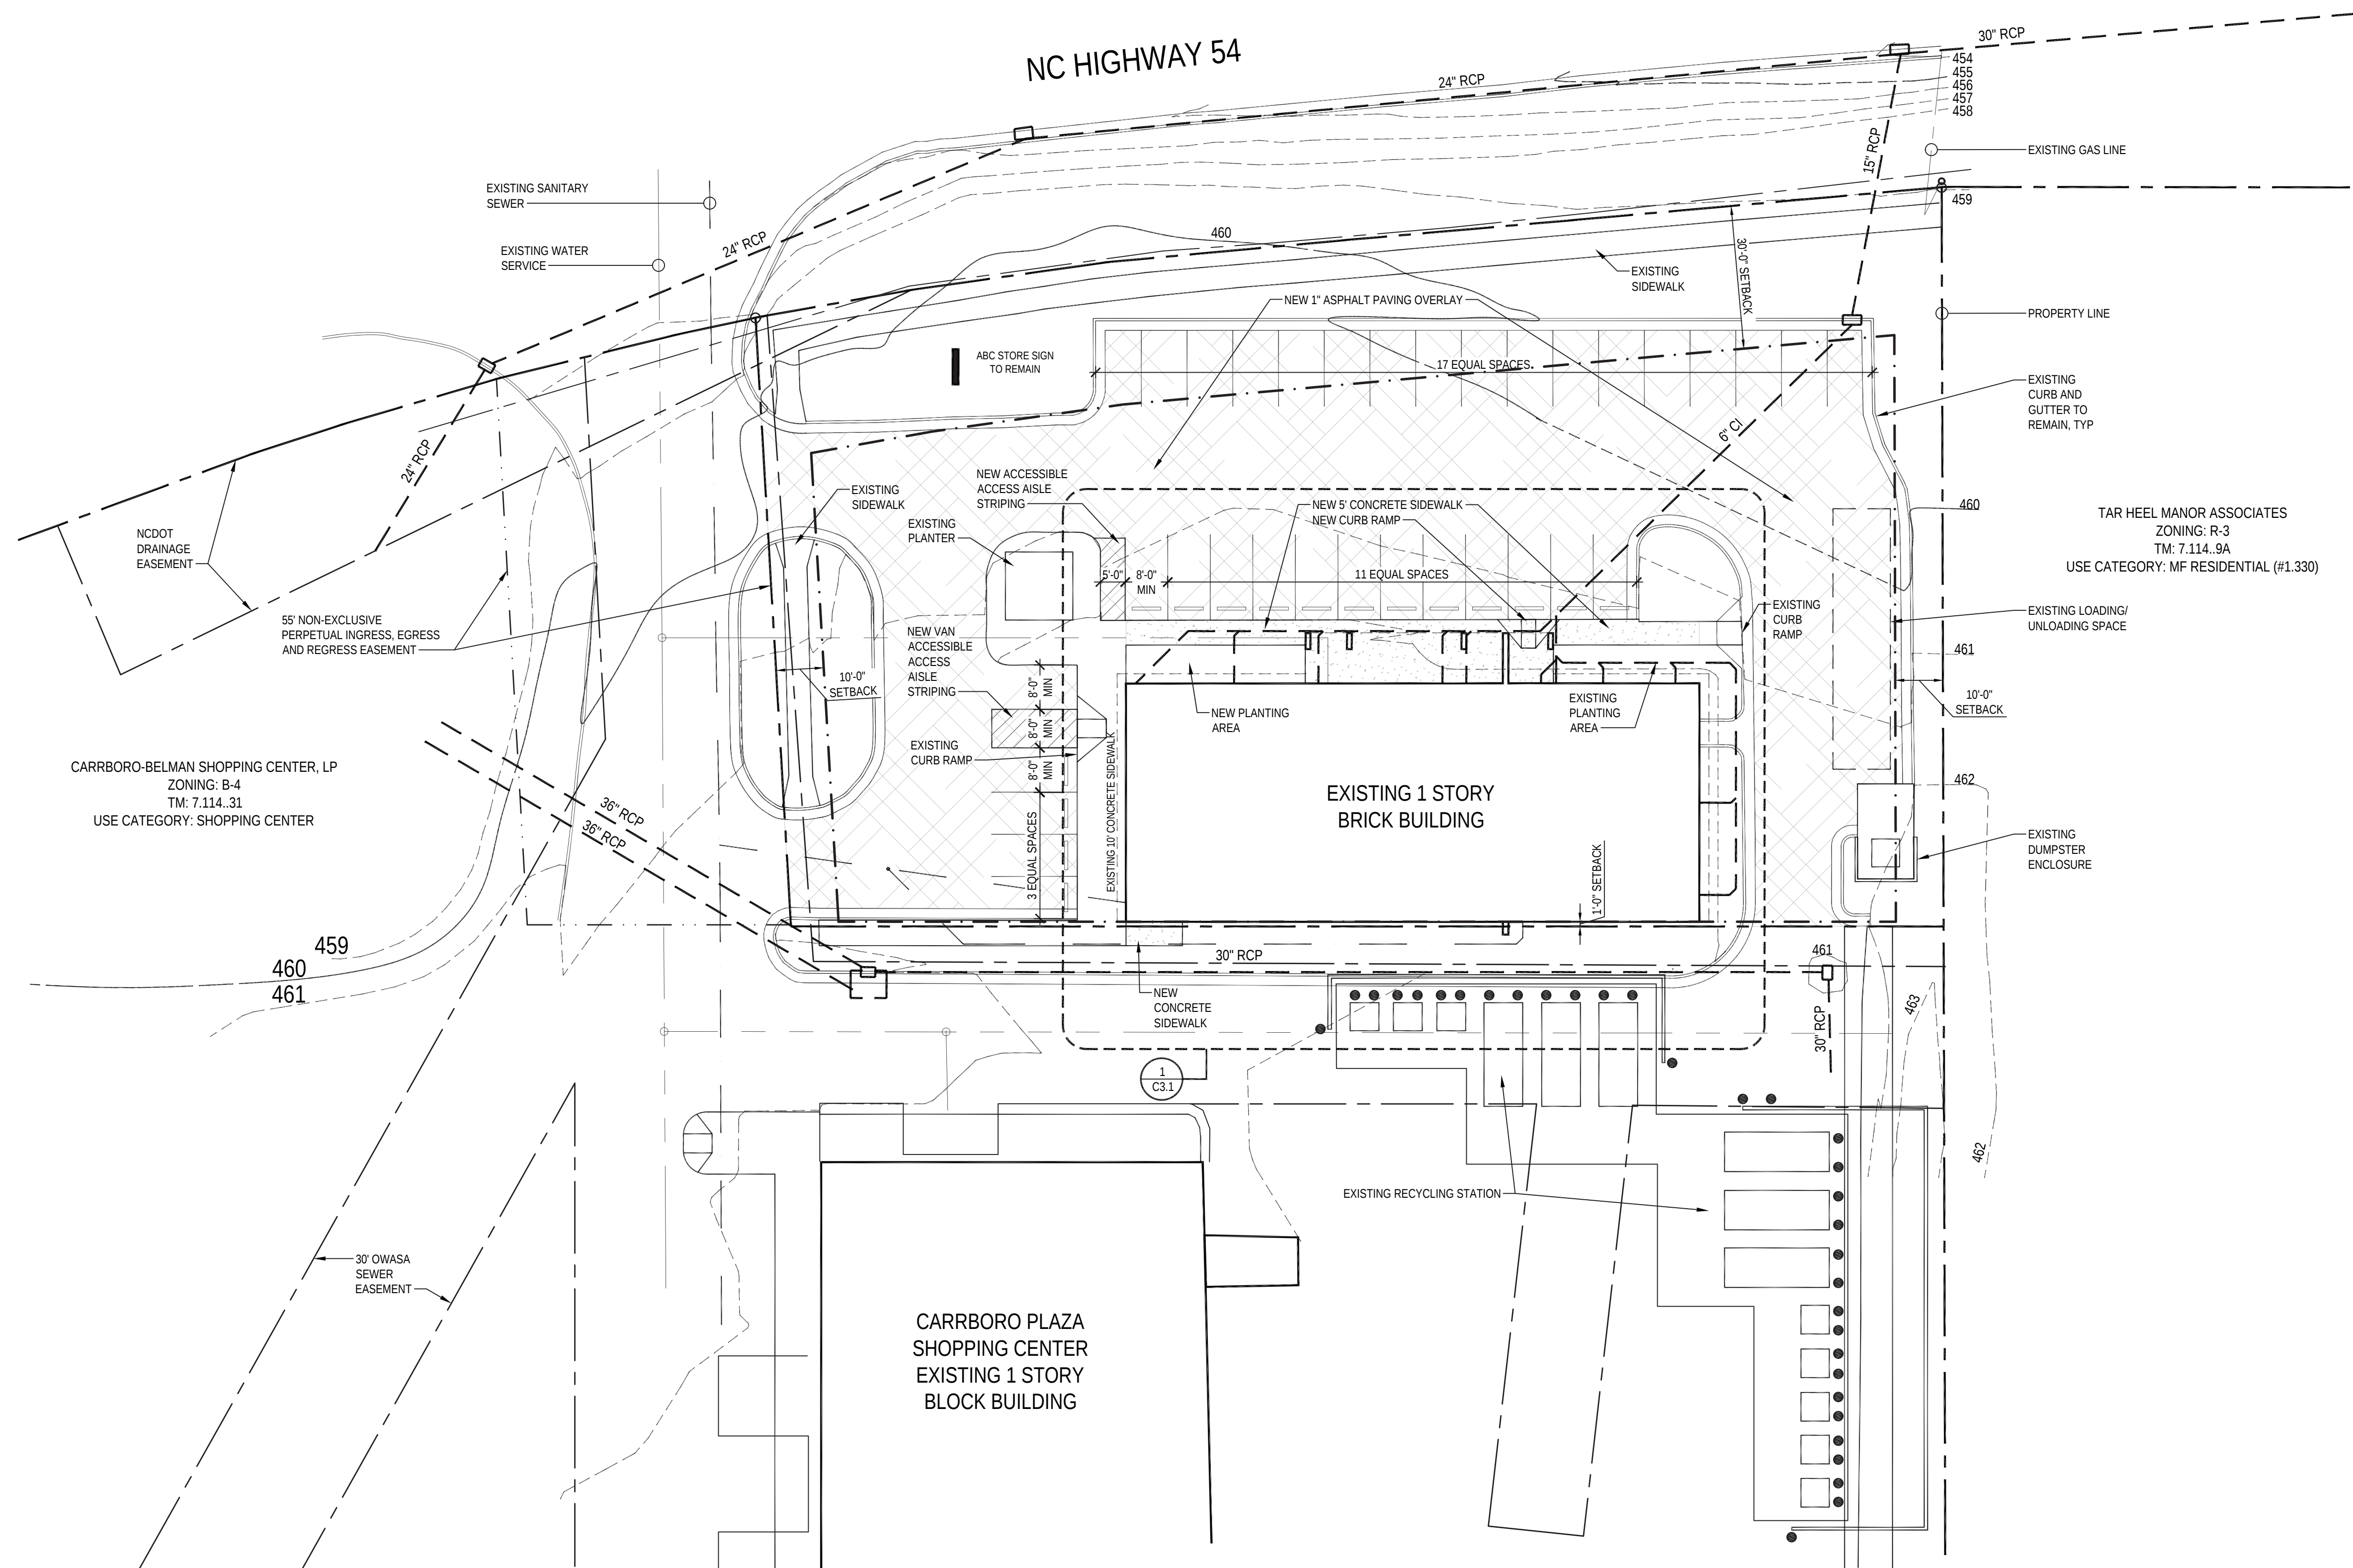

SITE PLAN
SCALE: 1"=20'

1

These drawings have been commissioned for this construction project and remain the property of Tise-Kiester Architects. No reproduction or use is allowed without first obtaining the Architect's written consent.


Carrboro
ABC

Carrboro, NC

Job Number: 1716

■ Date: 1.12.18

■ Revisions:

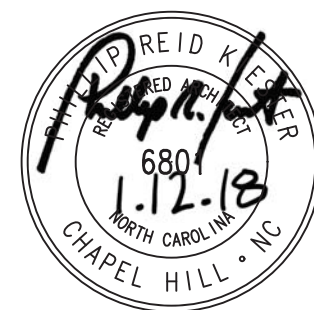


ENLARGED SITE PLAN

Sheet

C3.1

1

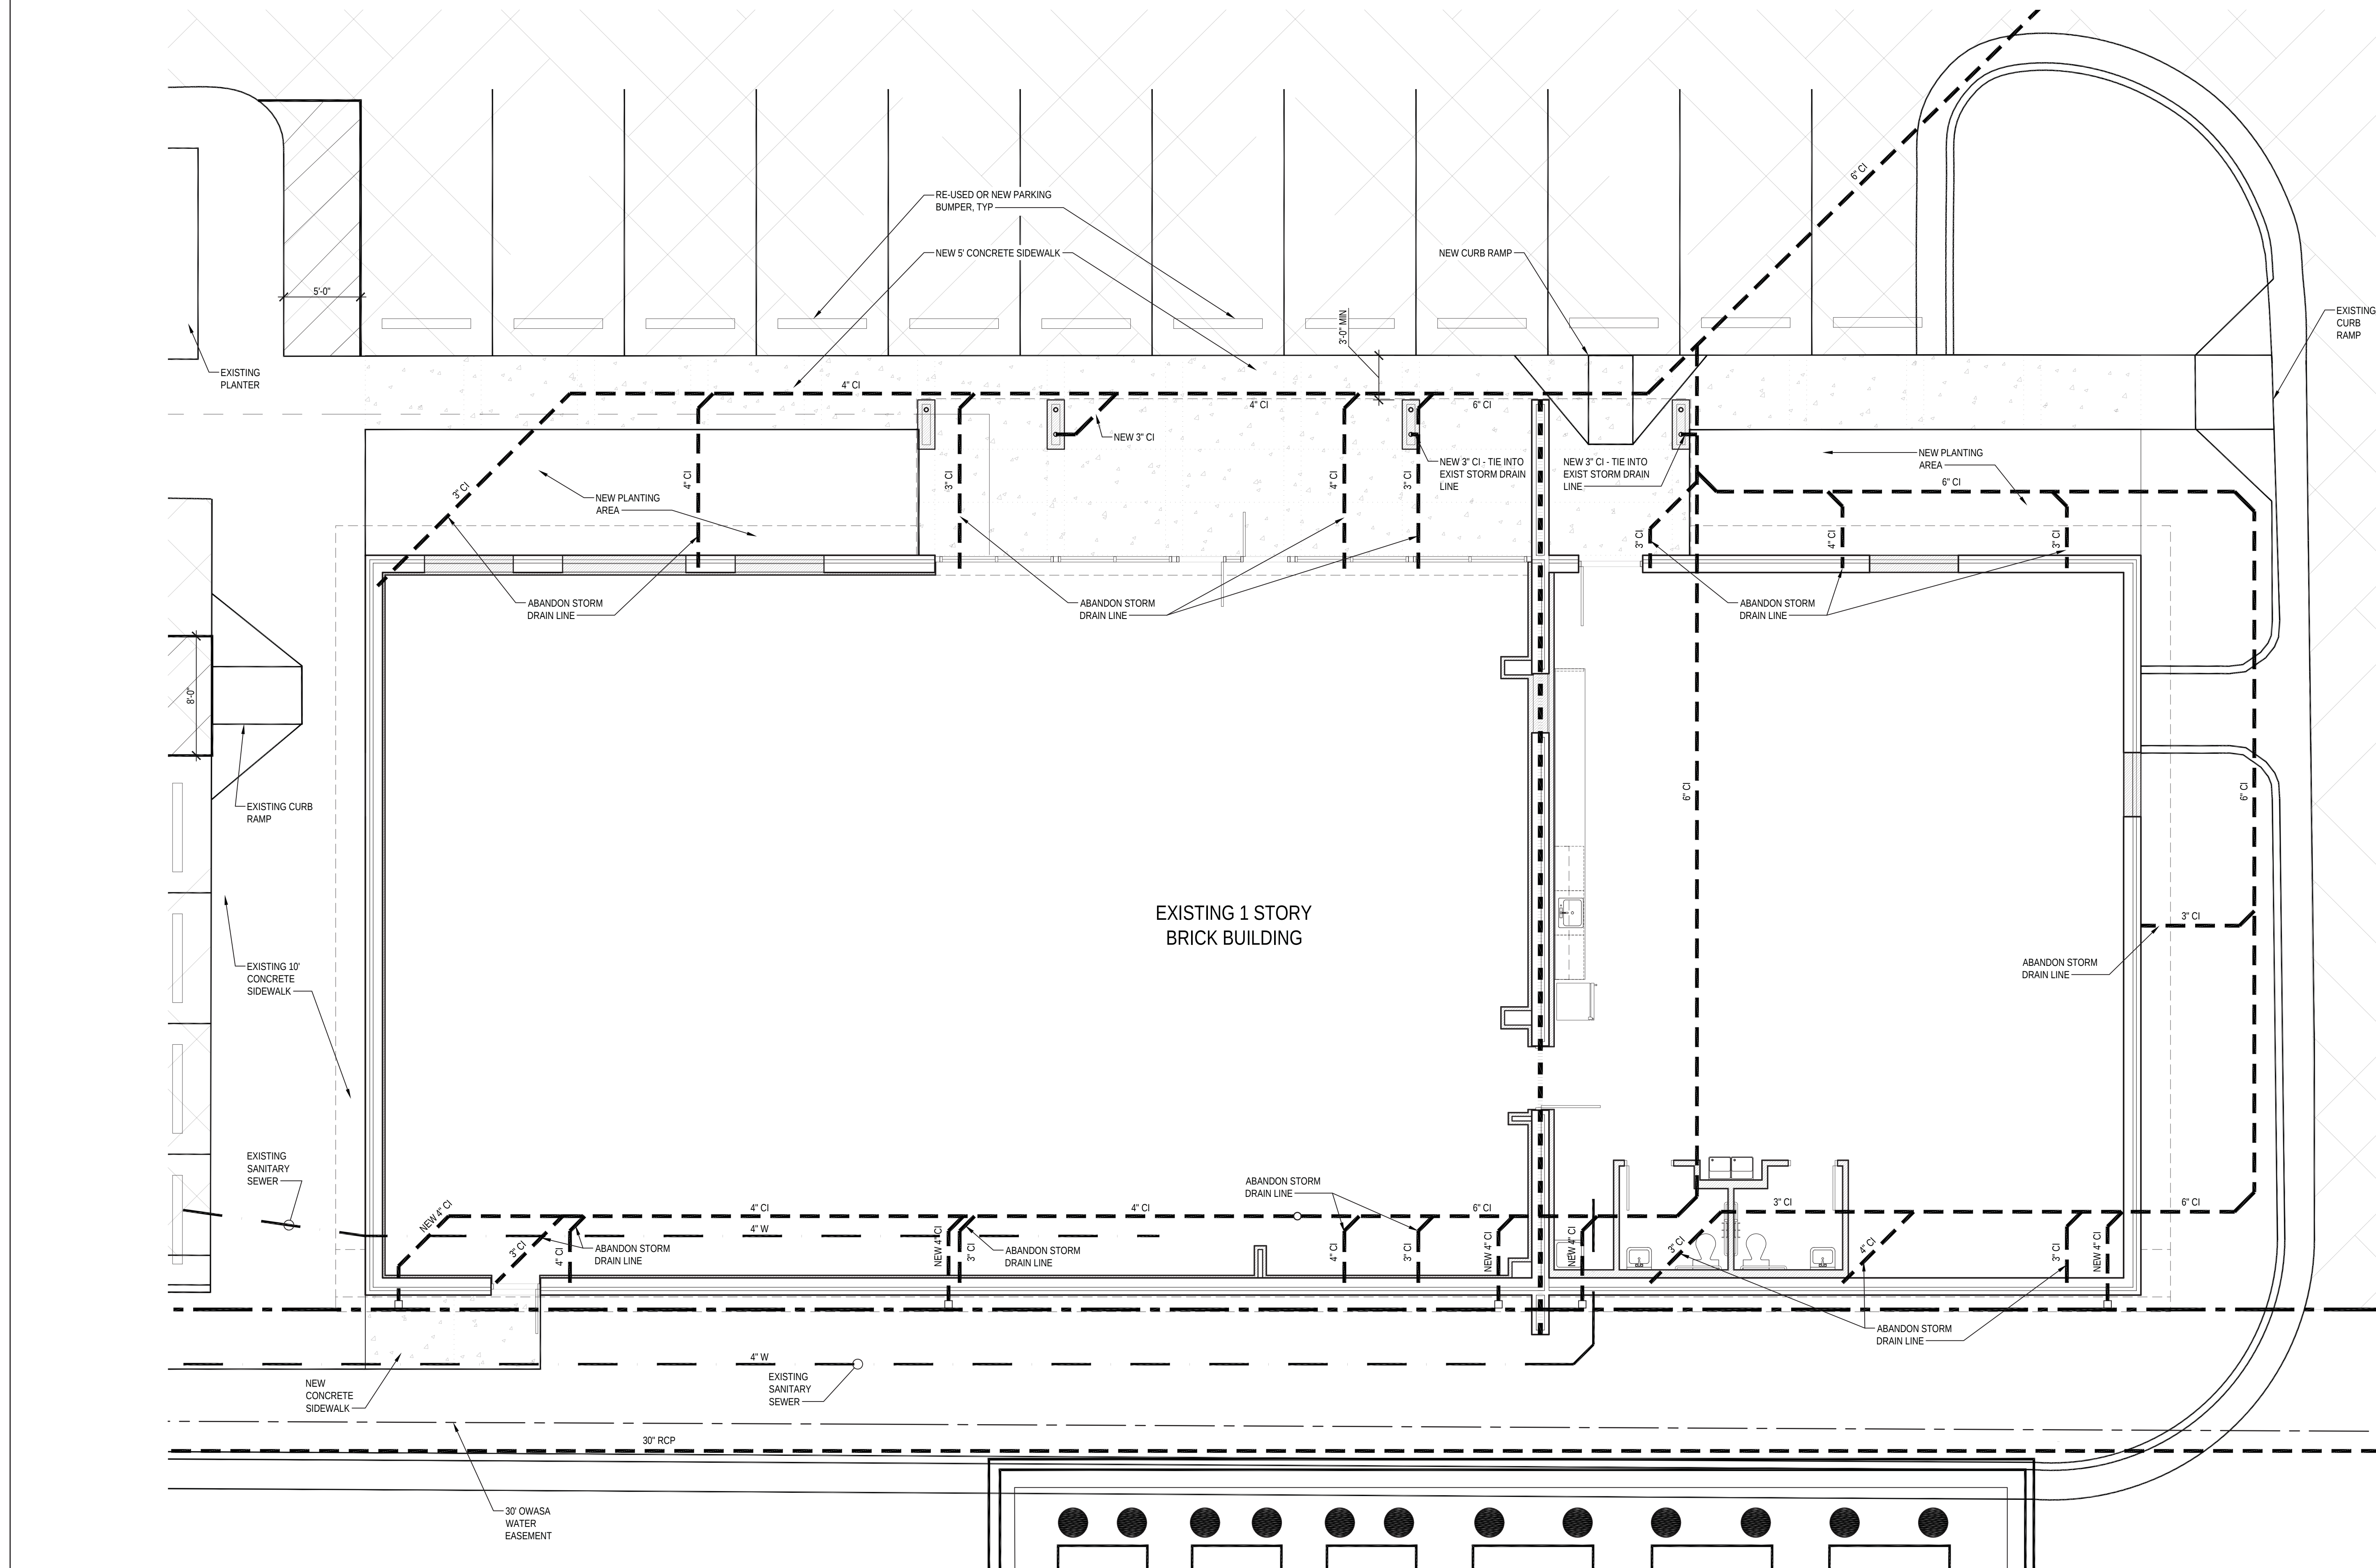


PLAN NORTH

0 1' 2' 4' 8'

ENLARGED SITE PLAN

SCALE: $\frac{3}{16}"=1'-0"$

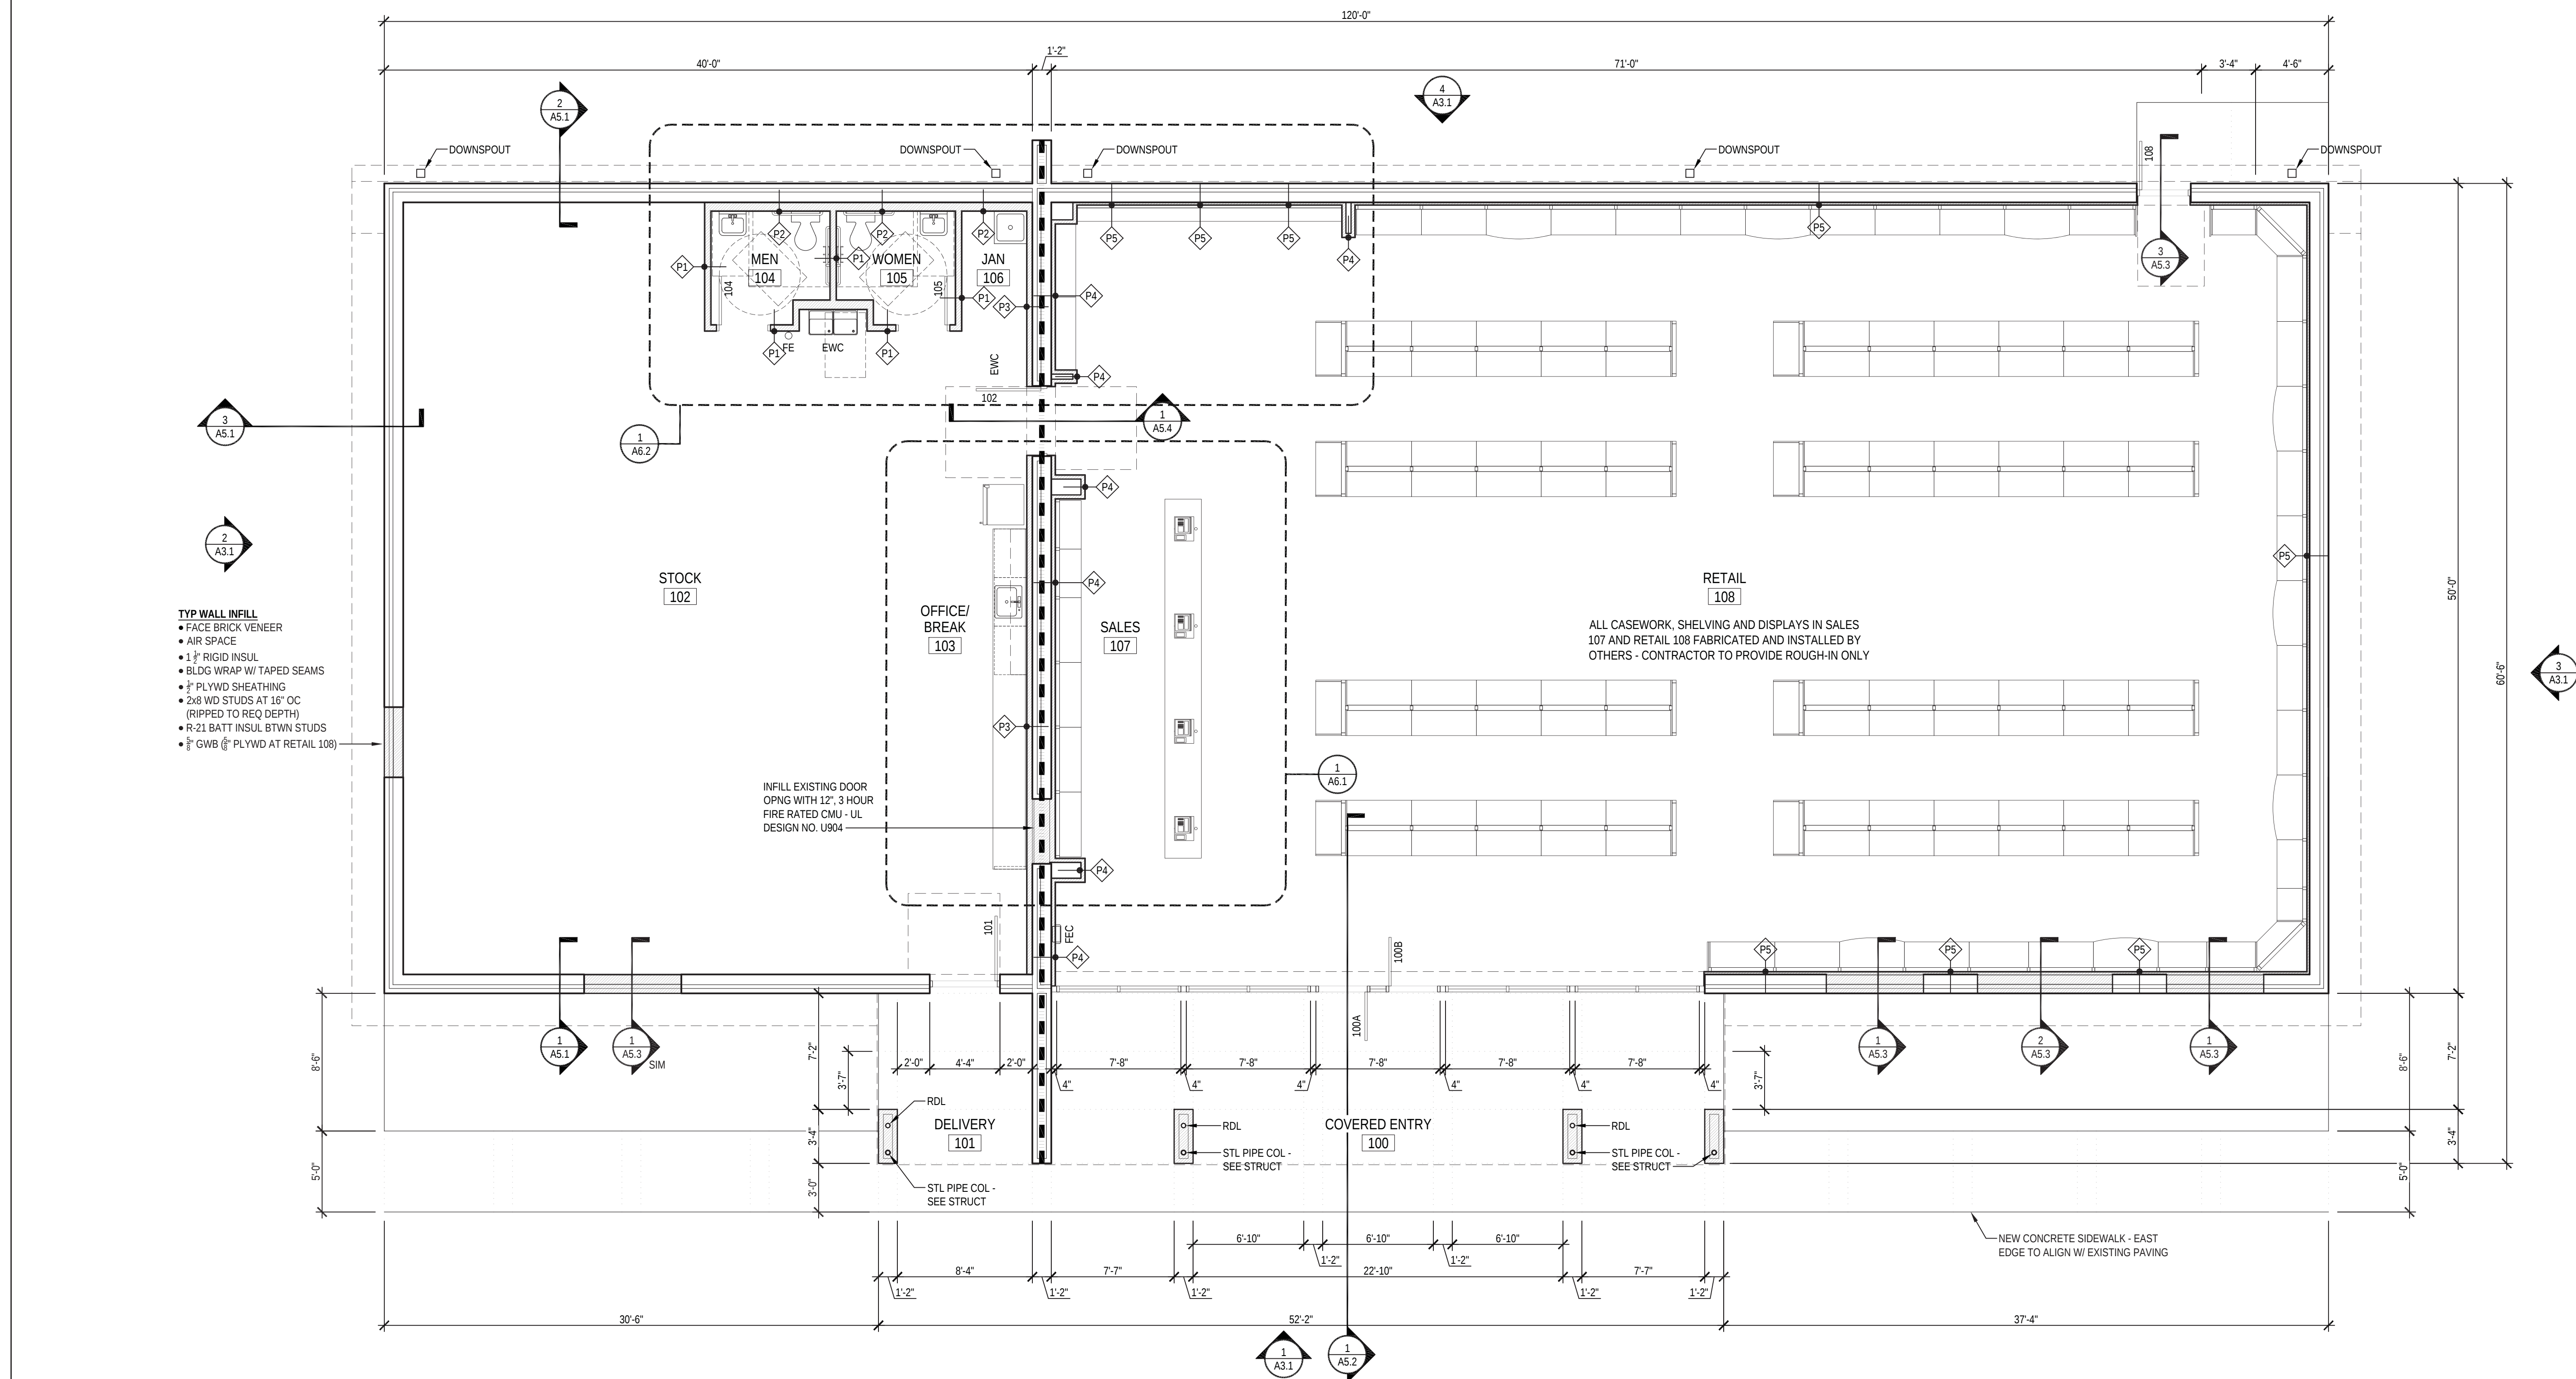[illegible]

These drawings have been commissioned for this construction project and remain the property of Tise-Kiester Architects. No reproduction or use is allowed without first obtaining the Architect's written consent.


Carrboro ABC

Carrboro, NC

Job Number: 1716

■ Date: 1.12.18

■ Revisions:

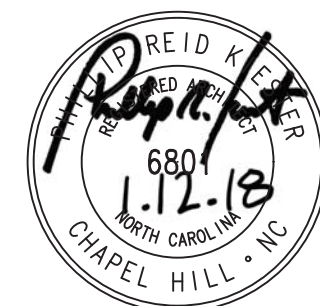

FLOOR PLAN

Sheet

A1.1

SCALE: $\frac{3}{16}"=1'-0"$



Existing View
NTS

4



Existing View
NTS

3



Existing View
NTS

2



Existing View
NTS

1

TISE · KIESTER
ARCHITECTS

TKa


119 E. Franklin St., Suite 300
Chapel Hill, NC 27514
Tel. 919.967.0158
Fax 919.967.0159
www.tisekiester.com

These drawings have been commissioned for this construction project and remain the property of Tise-Kiester Architects. No reproduction or use is allowed without first obtaining the Architect's written consent.

Carrboro
ABC

Carrboro, NC


- Job Number: 0000
- Date: 01.15.18
- Revisions:

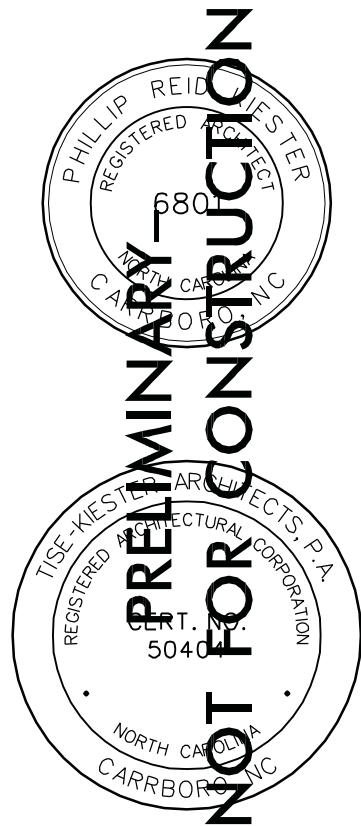

Existing
Conditions

Sheet

E1.1

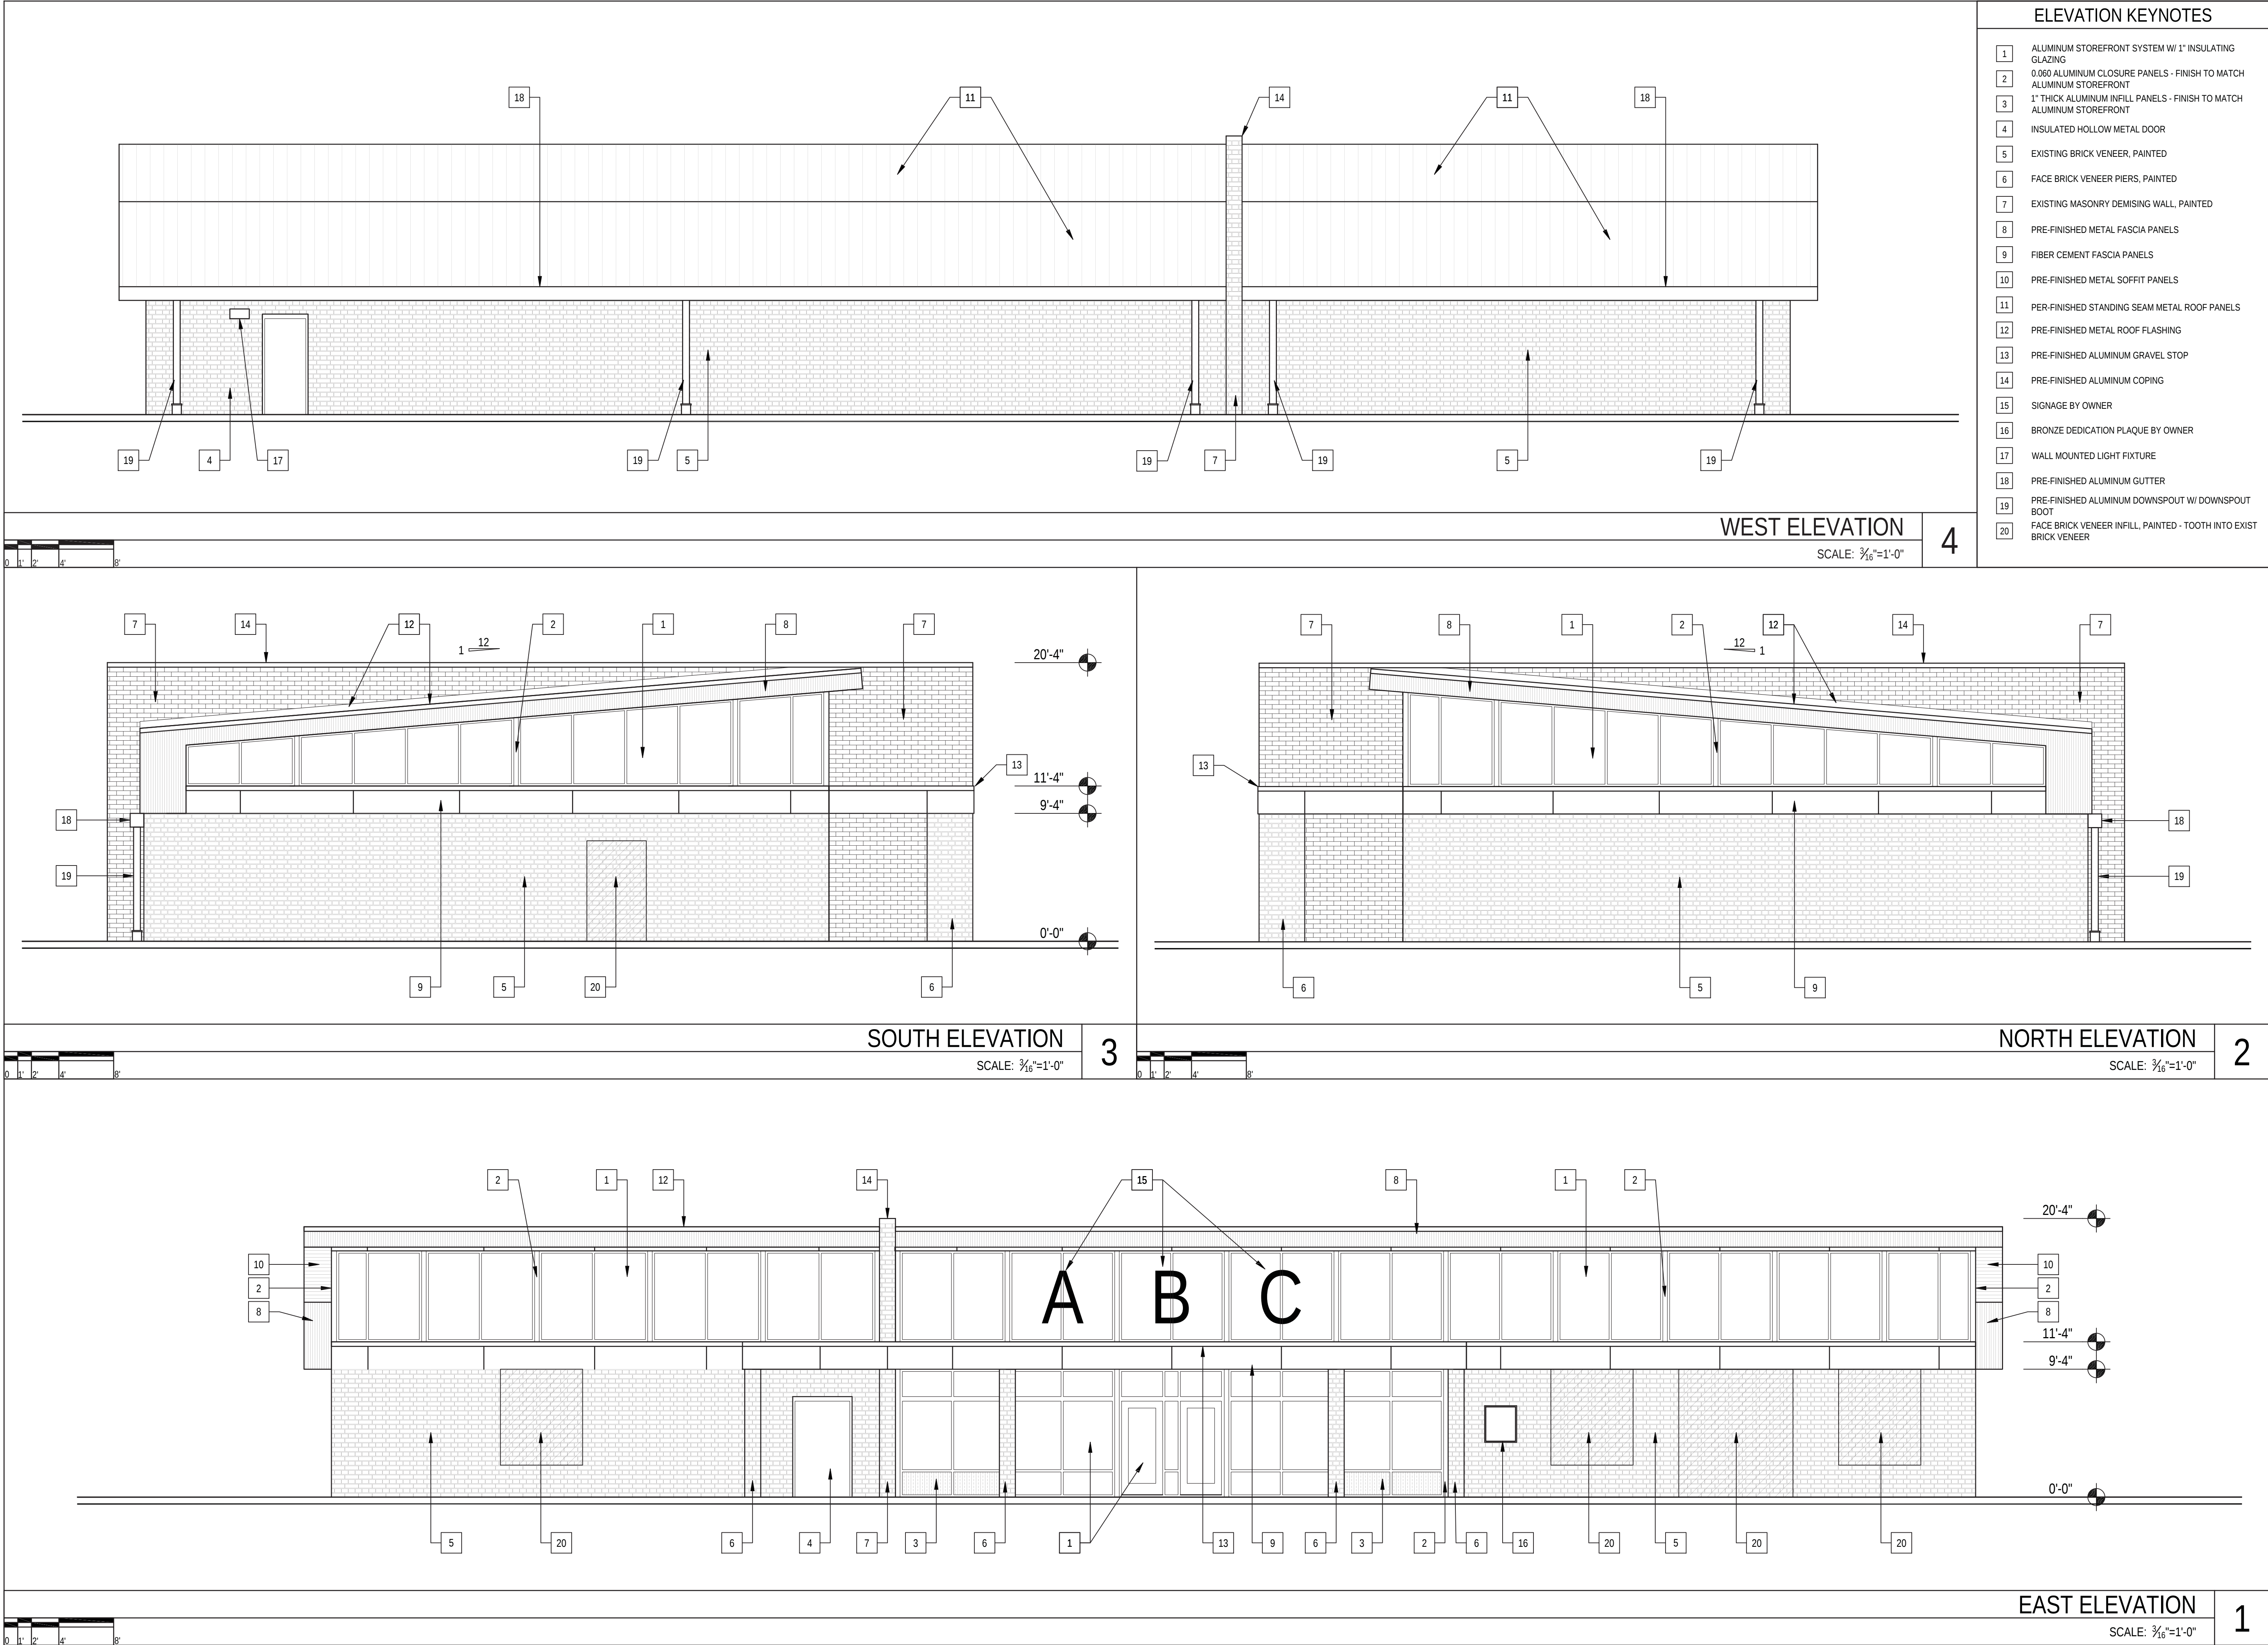

ELEVATION KEYNOTES

- 1 ALUMINUM STOREFRONT SYSTEM W/ 1" INSULATING GLAZING
- 2 0.060 ALUMINUM CLOSURE PANELS - FINISH TO MATCH ALUMINUM STOREFRONT
- 3 1" THICK ALUMINUM INFILL PANELS - FINISH TO MATCH ALUMINUM STOREFRONT
- 4 INSULATED HOLLOW METAL DOOR
- 5 EXISTING BRICK VENEER, PAINTED
- 6 FACE BRICK VENEER PIERS, PAINTED
- 7 EXISTING MASONRY DEMISING WALL, PAINTED
- 8 PRE-FINISHED METAL FASCIA PANELS
- 9 FIBER CEMENT FASCIA PANELS
- 10 PRE-FINISHED METAL SOFFIT PANELS
- 11 PER-FINISHED STANDING SEAM METAL ROOF PANELS
- 12 PRE-FINISHED METAL ROOF FLASHING
- 13 PRE-FINISHED ALUMINUM GRAVEL STOP
- 14 PRE-FINISHED ALUMINUM COPING
- 15 SIGNAGE BY OWNER
- 16 BRONZE DEDICATION PLAQUE BY OWNER
- 17 WALL MOUNTED LIGHT FIXTURE
- 18 PRE-FINISHED ALUMINUM GUTTER
- 19 PRE-FINISHED ALUMINUM DOWNSPOUT W/ DOWNSPOUT BOOT
- 20 FACE BRICK VENEER INFILL, PAINTED - TOOTH INTO EXIST BRICK VENEER

WEST ELEVATION

SCALE: 3/16"=1'-0"

4

SOUTH ELEVATION

SCALE: 3/16"=1'-0"

3

NORTH ELEVATION

SCALE: 3/16"=1'-0"

2

EAST ELEVATION

SCALE: 3/16"=1'-0"

1

TISE • KIESTER
ARCHITECTS

TKa


119 E. Franklin St. Suite 300
Chapel Hill, NC 27514
Tel: 919.967.0158
Fax: 919.967.0159
www.tisekiester.com

These drawings have been commissioned
for this construction project and remain the
property of Tise-Kiester Architects. No
reproduction or use is allowed without first
obtaining the Architect's written consent.

Carrboro
ABC

Carrboro, NC

Job Number: 1716
Date: 1.12.18
Revisions:

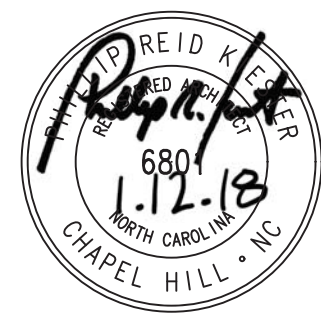

EXTERIOR
ELEVATIONS

Sheet

A3.1